




- KEYED ELECTRICAL NEW WORK SHEET NOTES**
1. FURNISH AND INSTALL NEW FIRE ALARM CONTROL PANEL. UTILIZE EXISTING FIRE ALARM TUB TO BEST EXTENT POSSIBLE. UTILIZE EXISTING 120V POWER. RECONNECT EXISTING FIRE ALARM DEPARTMENT COMMUNICATION WIRING. THE EXISTING ALL ATS SWITCHES, FIRE PUMP, GENERATOR, WET PIPE WATER FLOW, TAMPER SWITCHES, DRY PIPE SYSTEM, DUCT SMOKE DETECTOR, ETC SHALL BE RECONNECTED TO NEW FIRE ALARM CONTROL PANEL. PROVIDE FIRE ALARM RELAY, MONITOR MODULE, OR OTHER DEVICE AS REQUIRED.
 2. FURNISH AND INSTALL KEYBOX FOR THE KEY THAT REQUIRED FOR THE FIRE DEPARTMENT.
 3. FURNISH AND INSTALL 32" TOUCH SCREEN MONITOR FOR THE FIRE ALARM GRAPHIC ANNUNCIATION. FURNISH AND INSTALL DUPLEX RECEPTACLE WITH 120V EMERGENCY BRANCH CIRCUIT FROM THE NEAREST EMERGENCY PANELBOARD.
 - A2. ALTERNATE 2: FURNISH AND INSTALL WEATHER PROOF VISUAL FIRE ALARM DEVICE. FURNISH AND INSTALL NEW WIRING AND CONDUIT AS REQUIRED CONTRACTOR TO DETERMINE BEST MOUNTING LOCATION BASE ON FIELD CONDITIONS.

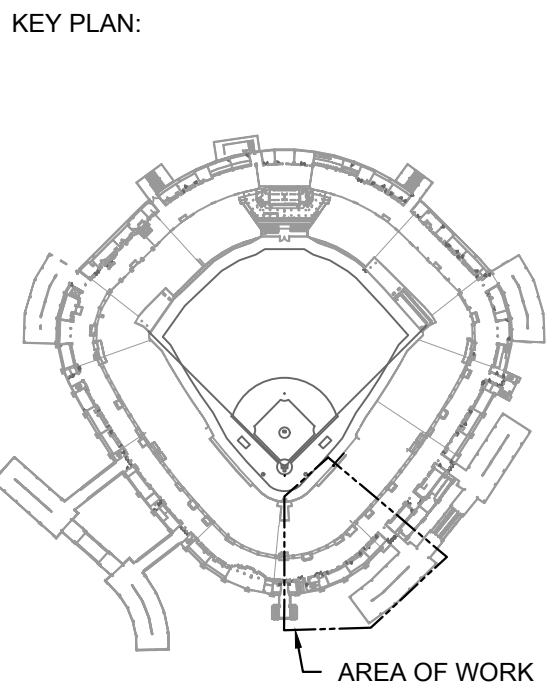

ISSUE/REVISION:		
REV.	DATE	DESCRIPTION
1	10/03/2023	ISSUED FOR BID
1	10/18/2023	ADDENDUM 1

PROJECT:
GUARANTEED RATE FIELD -
FIRE ALARM REPLACEMENT



333 W 35TH STREET,
CHICAGO, ILLINOIS 60616

DRAWING TITLE:
ELECTRICAL FIRE ALARM NEW
WORK PLAN - SERVICE LEVEL
- SECTION 6

DESIGNED BY: MR
CHECKED BY: BT
PROJECT NO: 22096
SCALE: 1/8" = 1'-0"

SHEET NO:
E1.006

10/03/2023 ISSUED FOR BID
PRELIMINARY - NOT FOR CONSTRUCTION

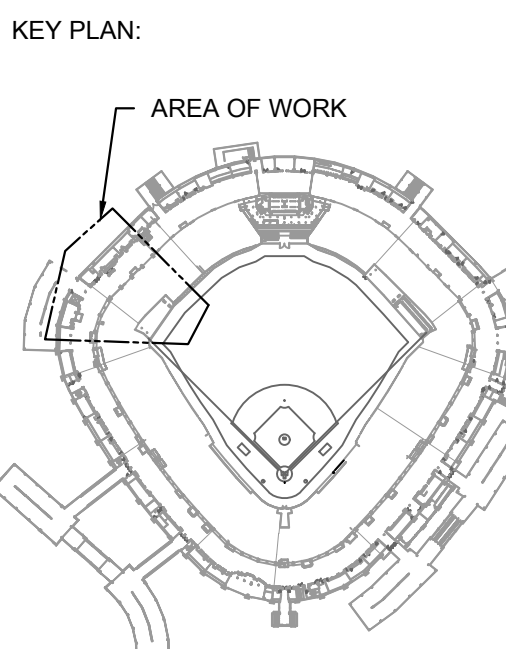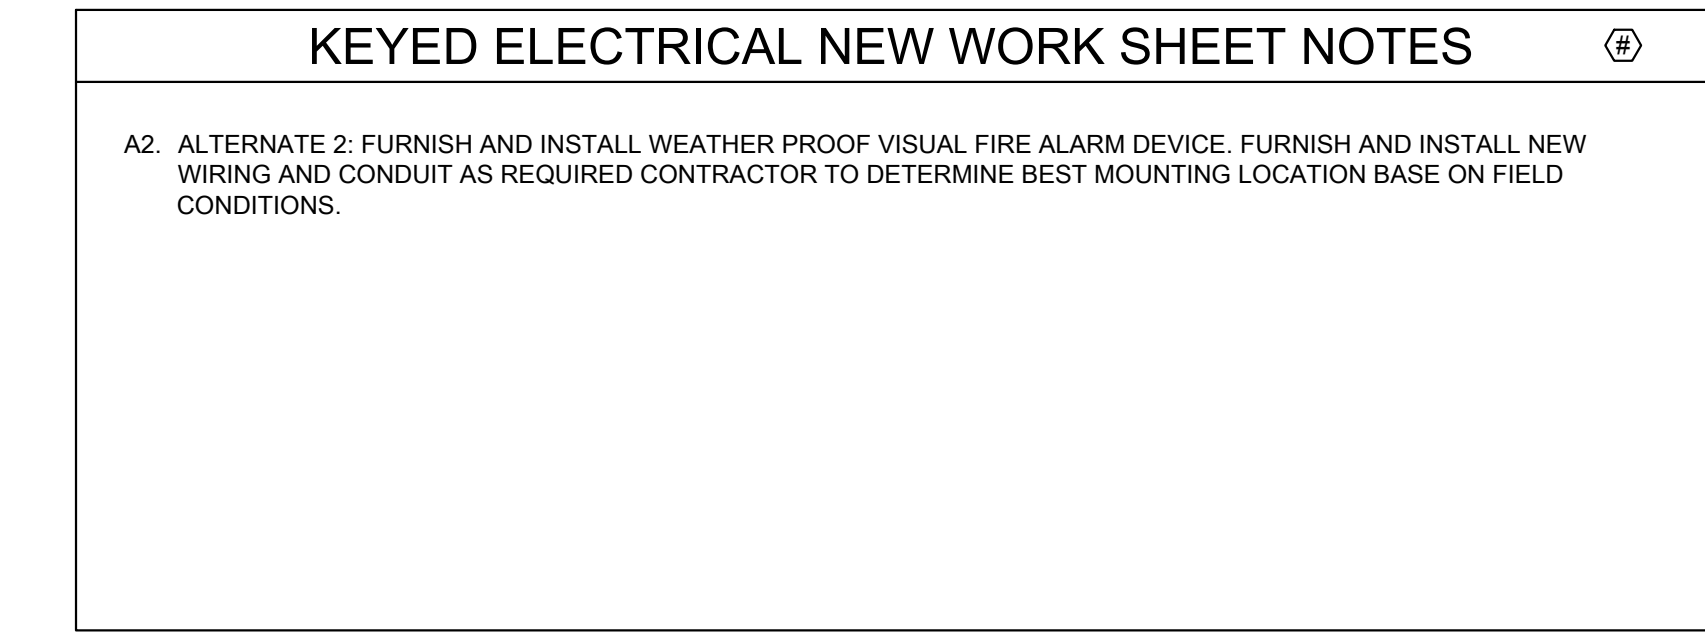


DESIGNED BY:	MR
CHECKED BY:	BT
PROJECT NO:	22096
SCALE:	1/8" = 1'-0"
SHEET NO.	

E1.010



KEYED ELECTRICAL NEW WORK SHEET NOTES

A2. ALTERNATE 2: FURNISH AND INSTALL WEATHER PROOF VISUAL FIRE ALARM DEVICE. FURNISH AND INSTALL NEW WIRING AND CONDUIT AS REQUIRED. CONTRACTOR TO DETERMINE BEST MOUNTING LOCATION BASED ON FIELD CONDITIONS.

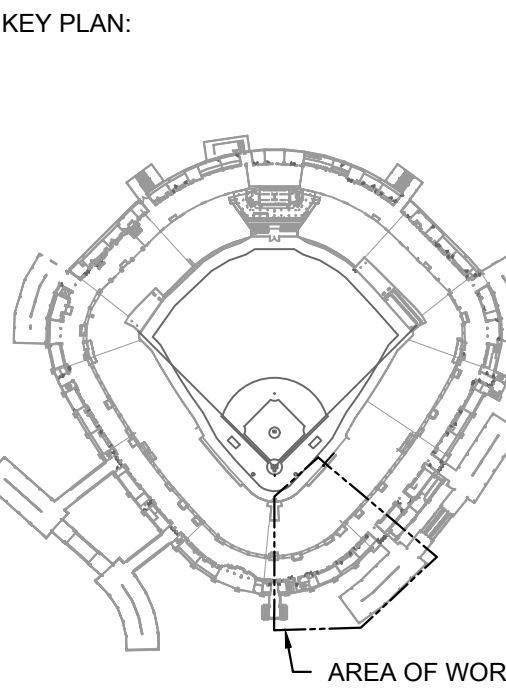

ISSUE/REVISION:		
REV.	DATE	DESCRIPTION
1	10/03/2023	ISSUED FOR BID
1	10/18/2023	ADDENDUM 1

PROJECT:
GUARANTEED RATE FIELD -
FIRE ALARM REPLACEMENT

333 W 35TH STREET,
CHICAGO, ILLINOIS 60616


DRAWING TITLE:
ELECTRICAL FIRE ALARM NEW
WORK PLAN - 300 LEVEL -
SECTION 6

DESIGNED BY:	MR
CHECKED BY:	BT
PROJECT NO:	22096
SCALE:	1/8" = 1'-0"
SHEET NO.	

1 ELECTRICAL FIRE ALARM NEW WORK PLAN - 300 LEVEL - SECTION 6 ENLARGED

10/03/2023 ISSUED FOR BID
PRELIMINARY - NOT FOR CONSTRUCTION


E1.306

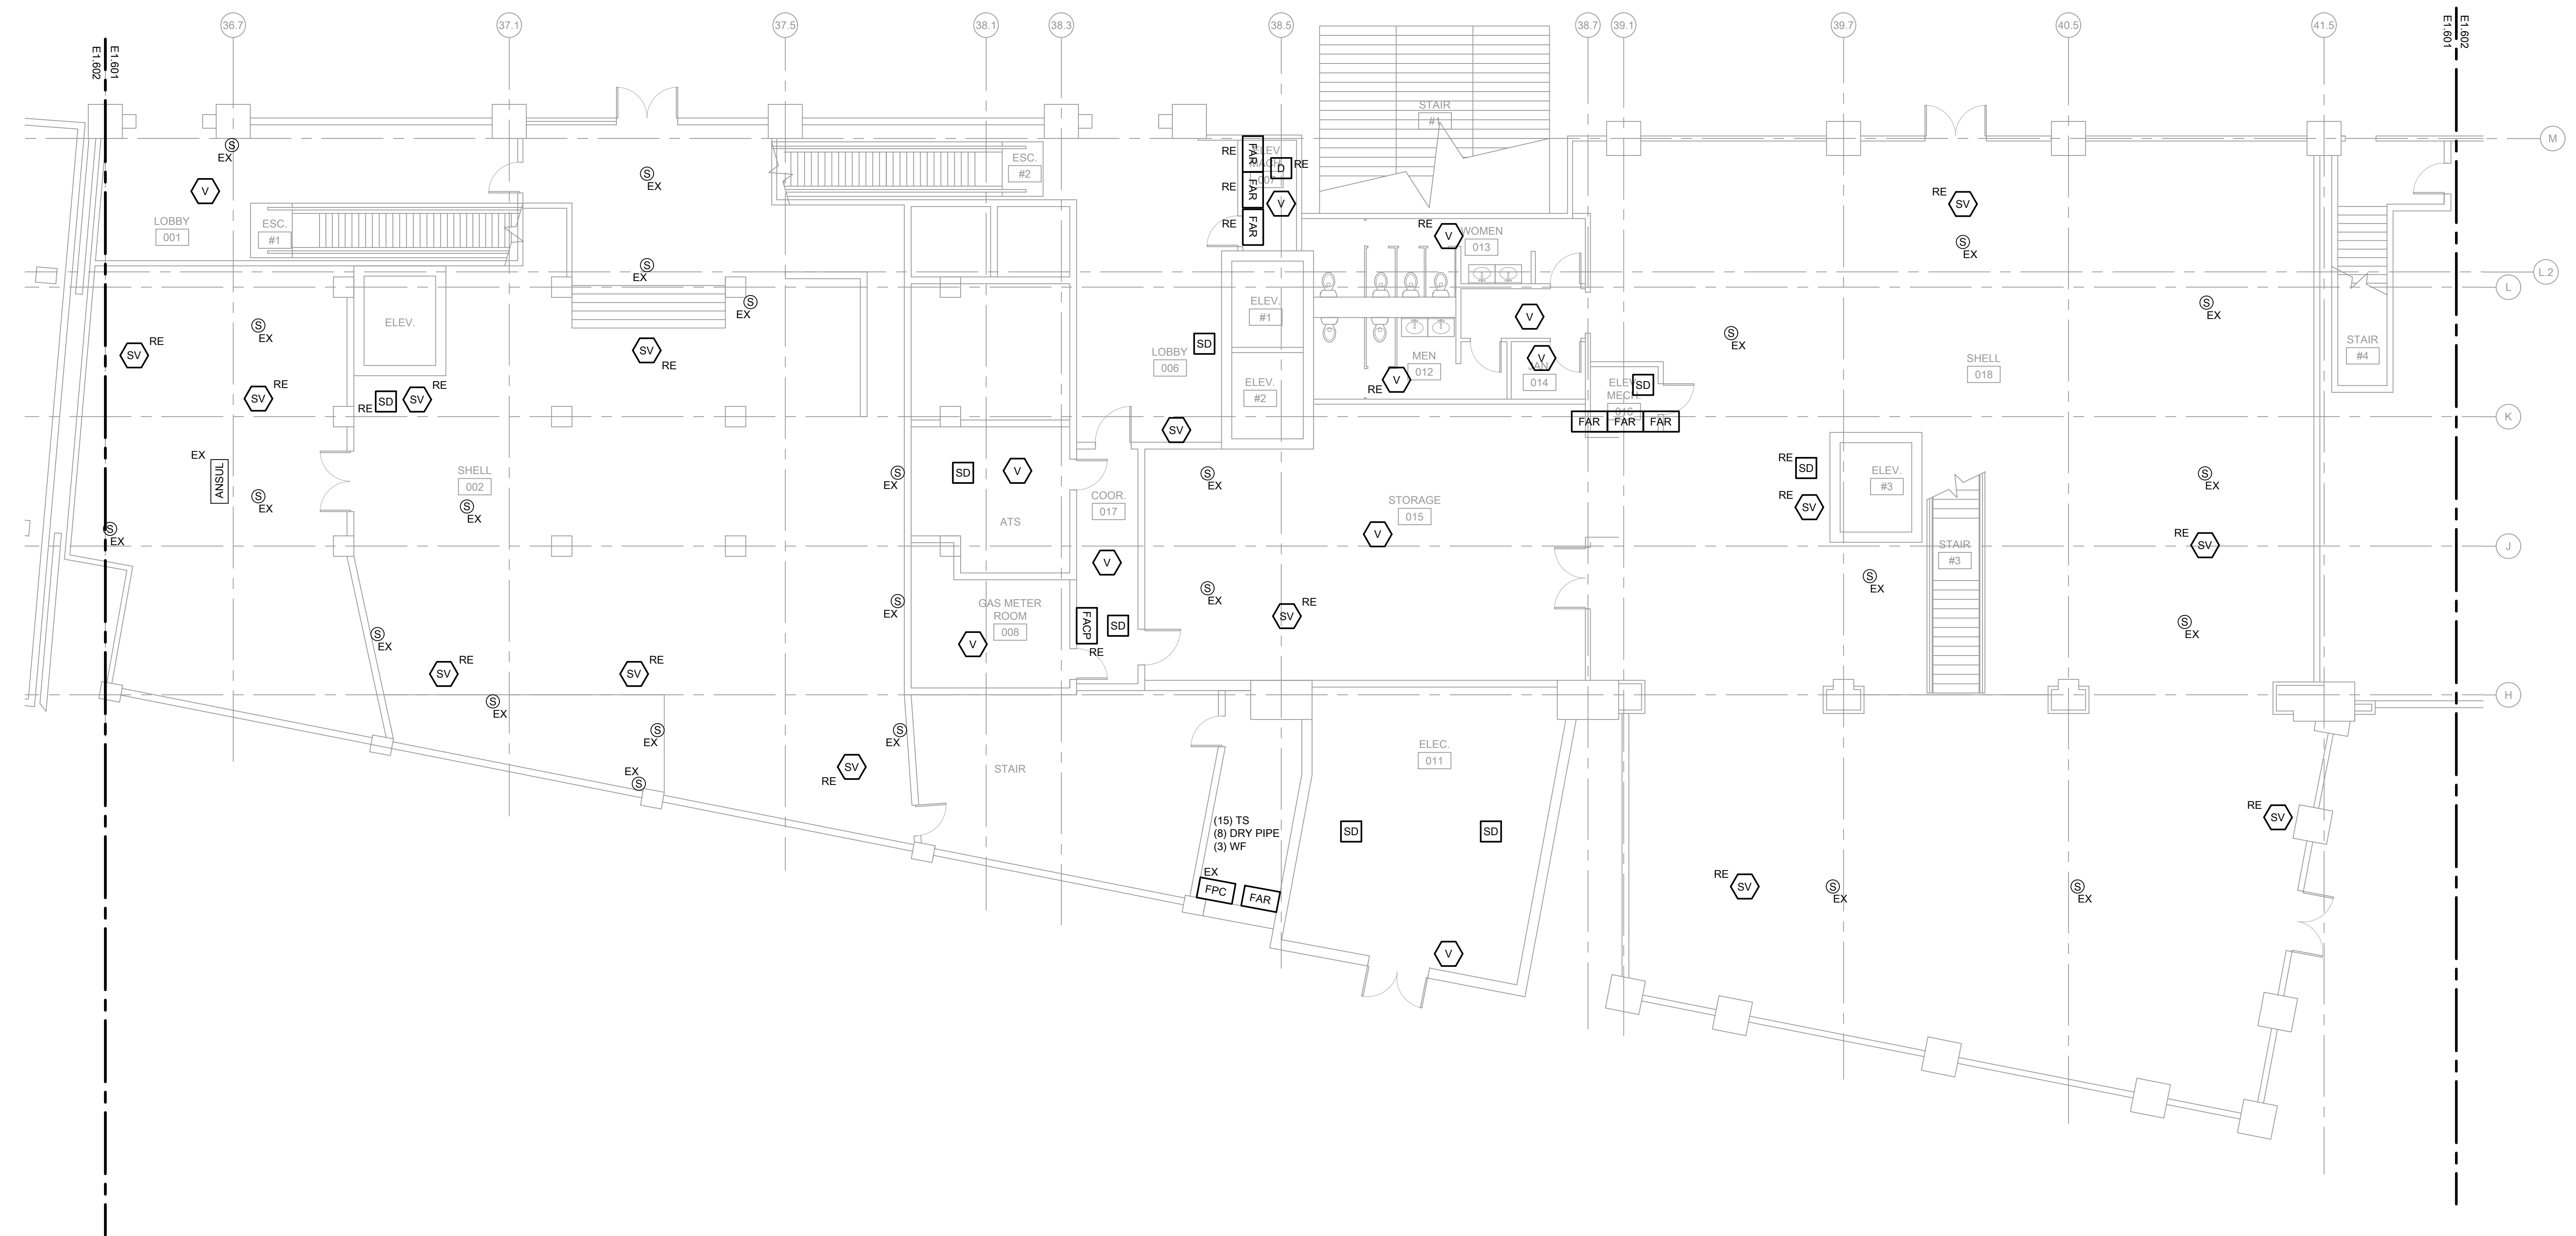

1 ELECTRICAL FIRE ALARM NEW WORK PLAN - PLAZA LEVEL - 320 W 35TH - SECTION 2

SCALE 1/8" = 1'-0"

KEY PLAN:

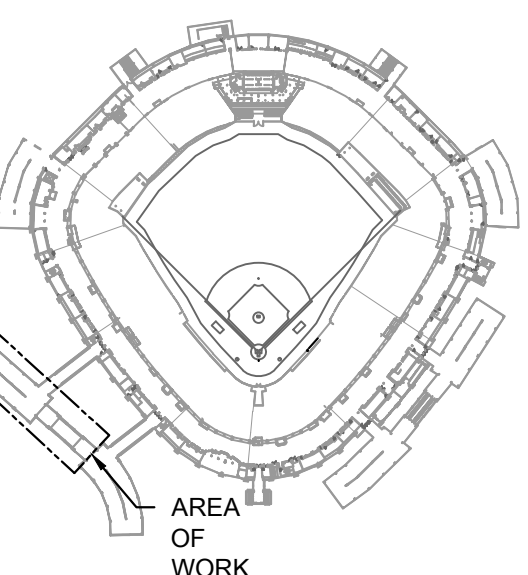

ISSUE/REVISION:

REV.	DATE	DESCRIPTION
1	10/03/2023	ISSUED FOR BID
1	10/18/2023	ADDENDUM 1

PROJECT:

GUARANTEED RATE FIELD -
FIRE ALARM REPLACEMENT

333 W 35TH STREET,
CHICAGO, ILLINOIS 60616

DRAWING TITLE:

ELECTRICAL FIRE ALARM NEW
WORK PLAN - PLAZA LEVEL

DESIGNED BY:

MR

CHECKED BY:

BT

PROJECT NO:

22096

SCALE:

1/8" = 1'-0"

SHEET NO:


10/03/2023 ISSUED FOR BID

PRELIMINARY - NOT FOR CONSTRUCTION


E1.601

KEYED ELECTRICAL NEW WORK SHEET NOTES ⑥

A2. ALTERNATE 2: FURNISH AND INSTALL WEATHER PROOF VISUAL FIRE ALARM DEVICE. FURNISH AND INSTALL NEW WIRING AND CONDUIT AS REQUIRED. CONTRACTOR TO DETERMINE BEST MOUNTING LOCATION BASED ON FIELD CONDITIONS.

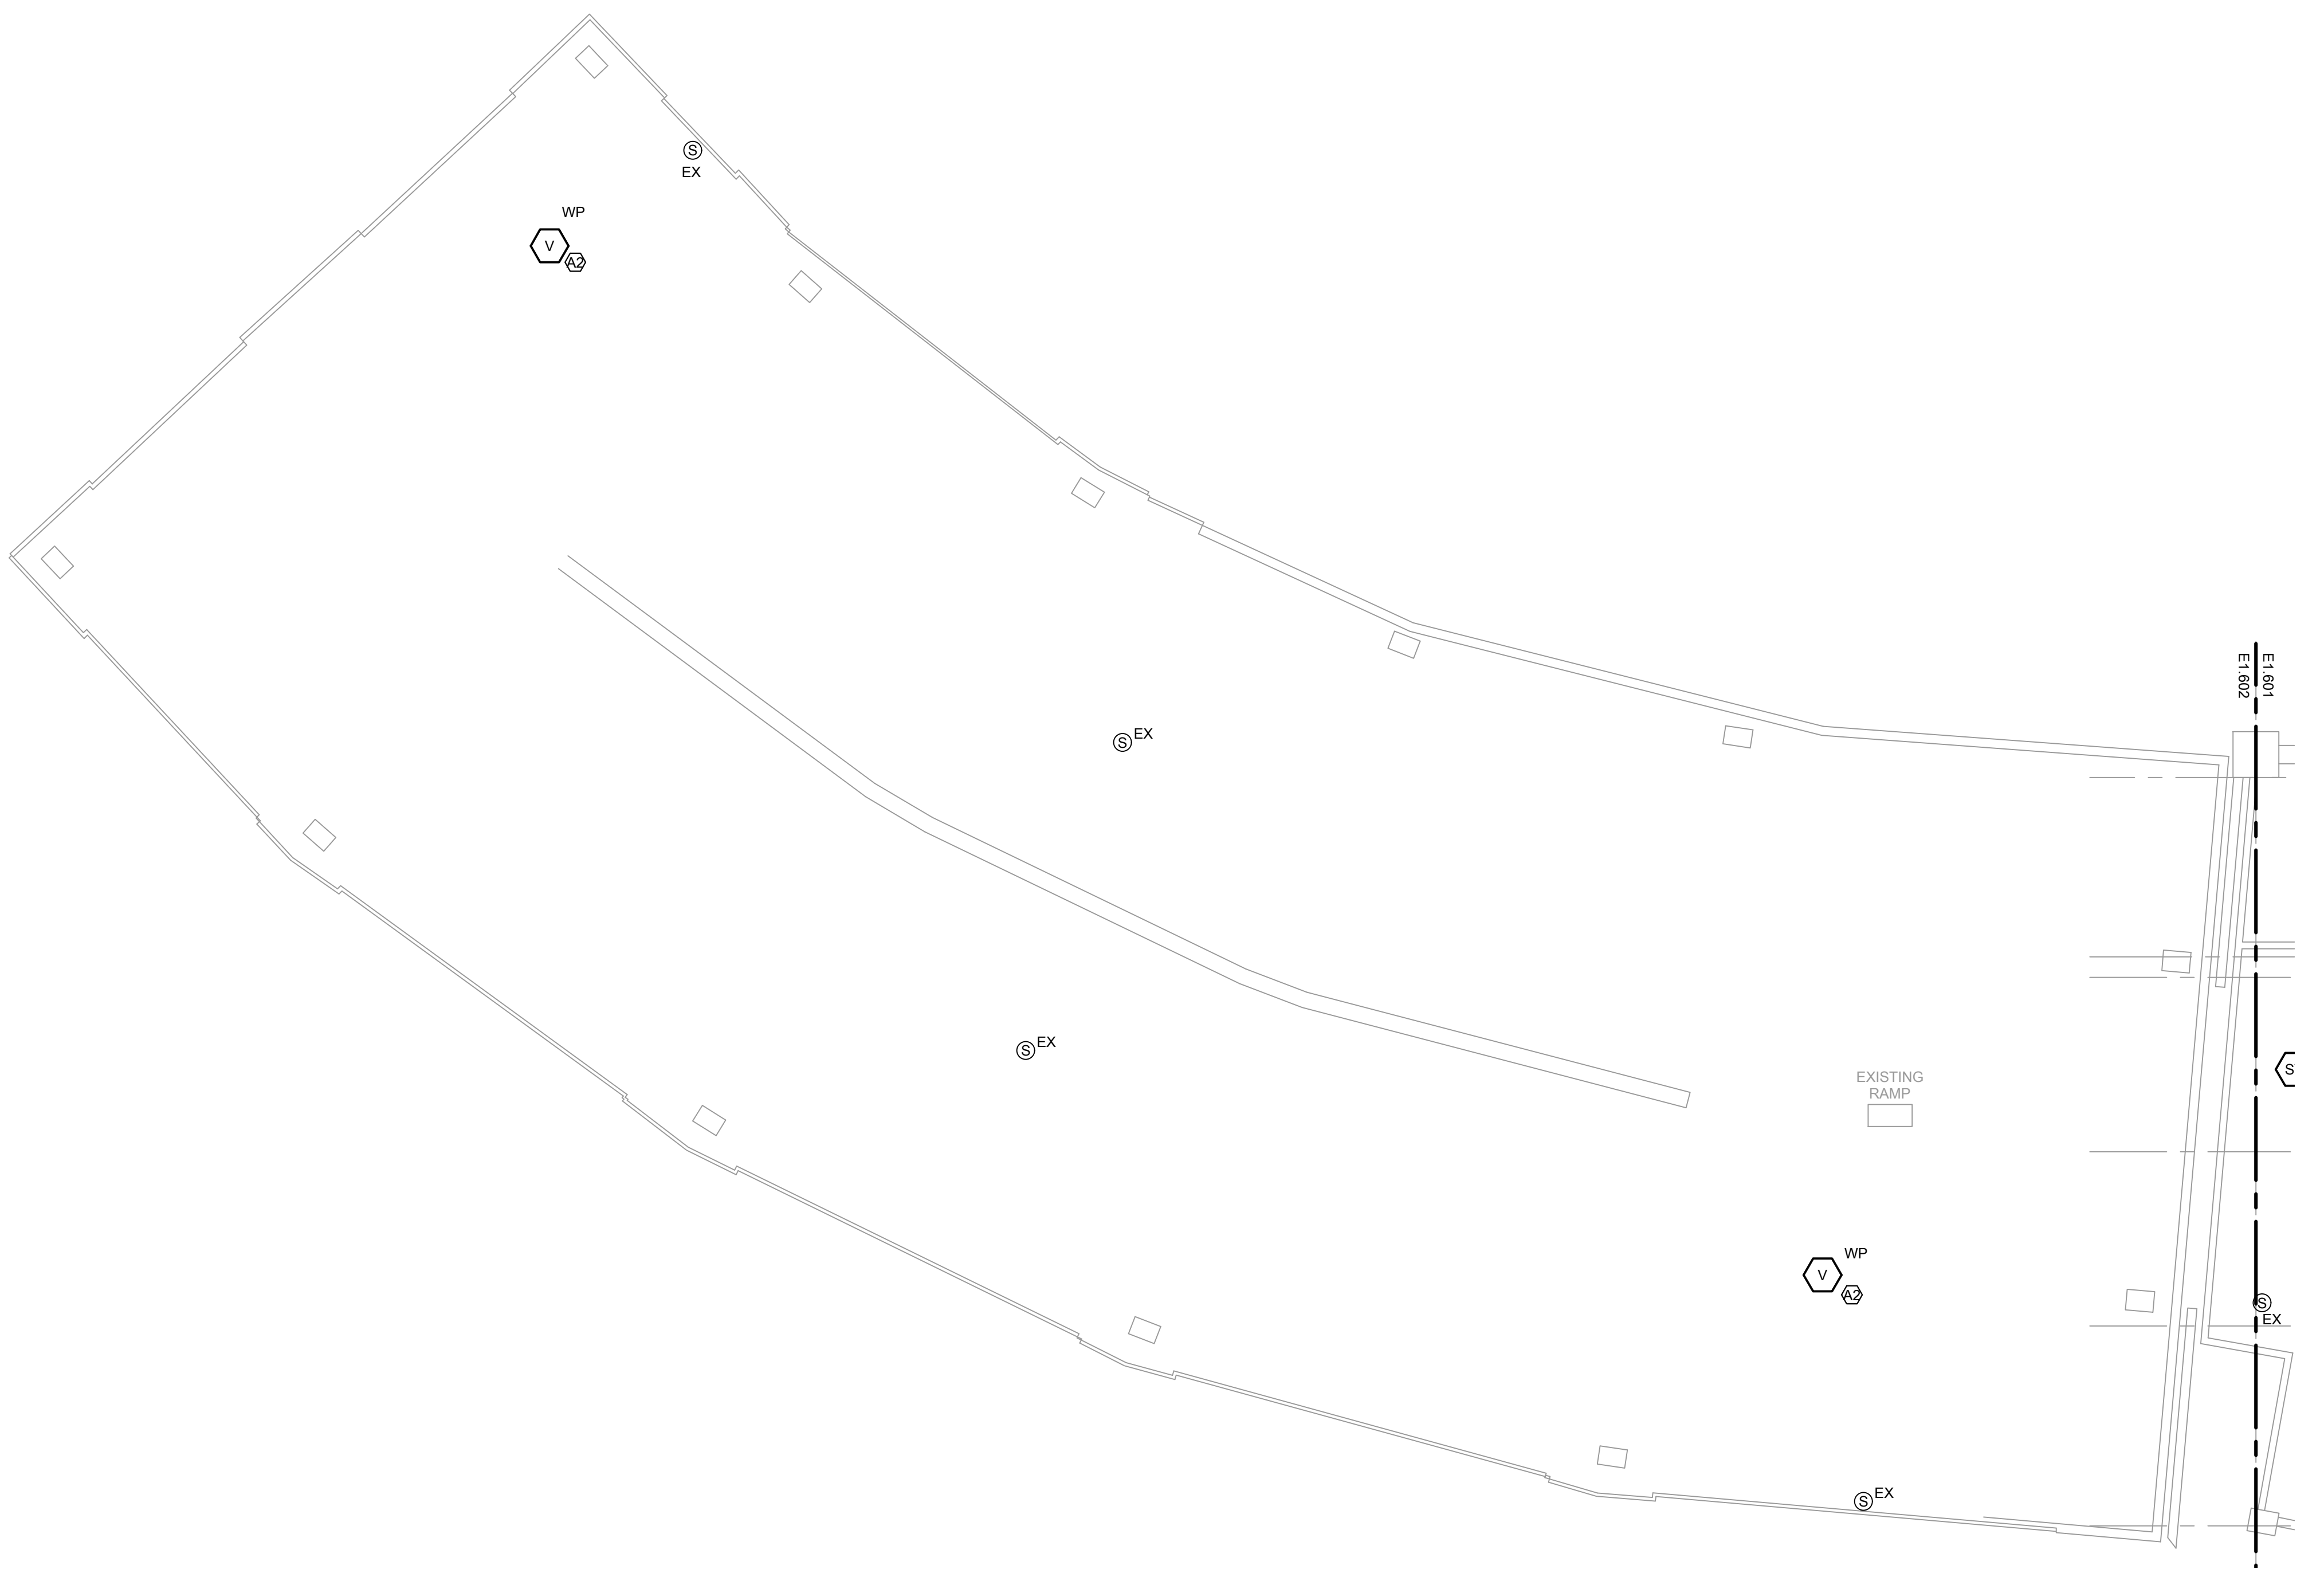


1 ELECTRICAL FIRE ALARM NEW WORK PLAN - PLAZA LEVEL - 320 W 35TH - SECTION 1

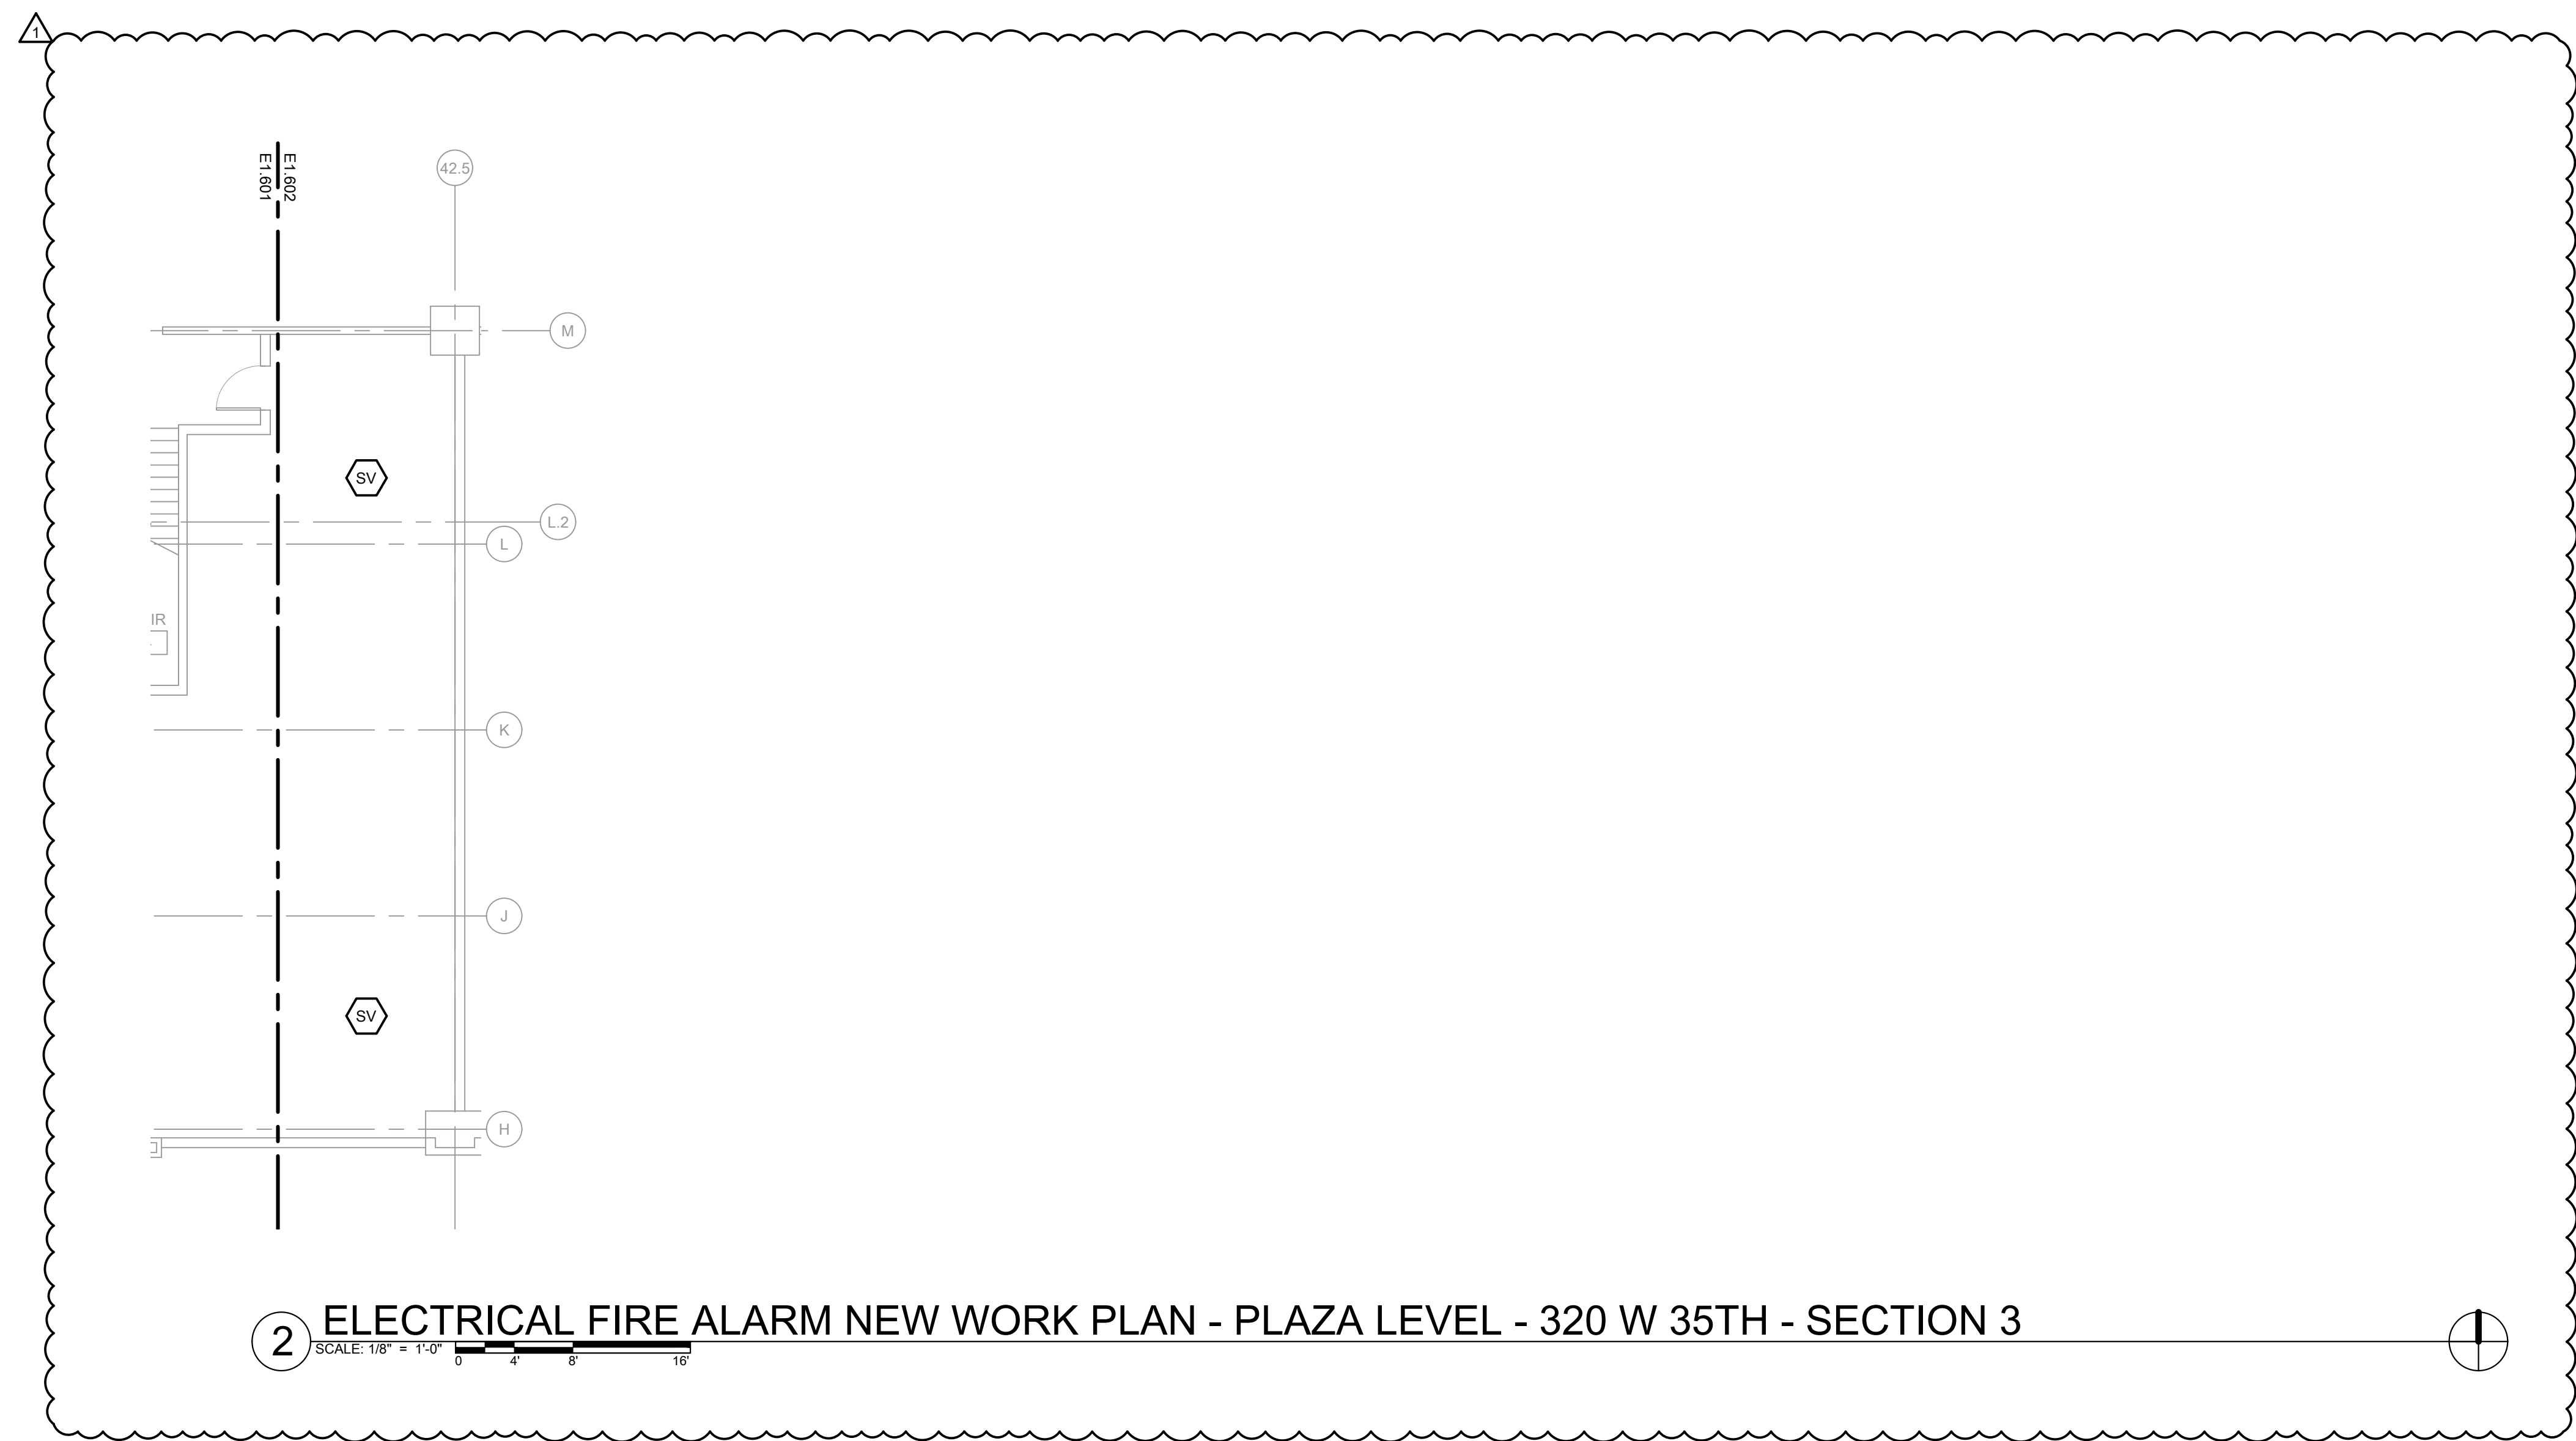

2 ELECTRICAL FIRE ALARM NEW WORK PLAN - PLAZA LEVEL - 320 W 35TH - SECTION 3



KEY PLAN:

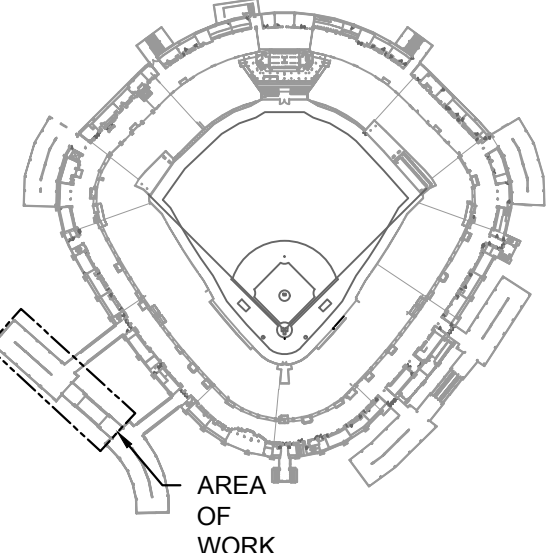

ISSUE/REVISION:

REV.	DATE	DESCRIPTION
1	10/03/2023	ISSUED FOR BID
1	10/18/2023	ADDENDUM 1

PROJECT:

GUARANTEED RATE FIELD - FIRE ALARM REPLACEMENT

333 W 35TH STREET, CHICAGO, ILLINOIS 60616


DRAWING TITLE:

ELECTRICAL FIRE ALARM NEW WORK PLAN - PLAZA LEVEL

DESIGNED BY:	MR
CHECKED BY:	BT
PROJECT NO:	22096
SCALE:	1/8" = 1'-0"
SHEET NO.	

10/03/2023 ISSUED FOR BID
PRELIMINARY - NOT FOR CONSTRUCTION


E1.602

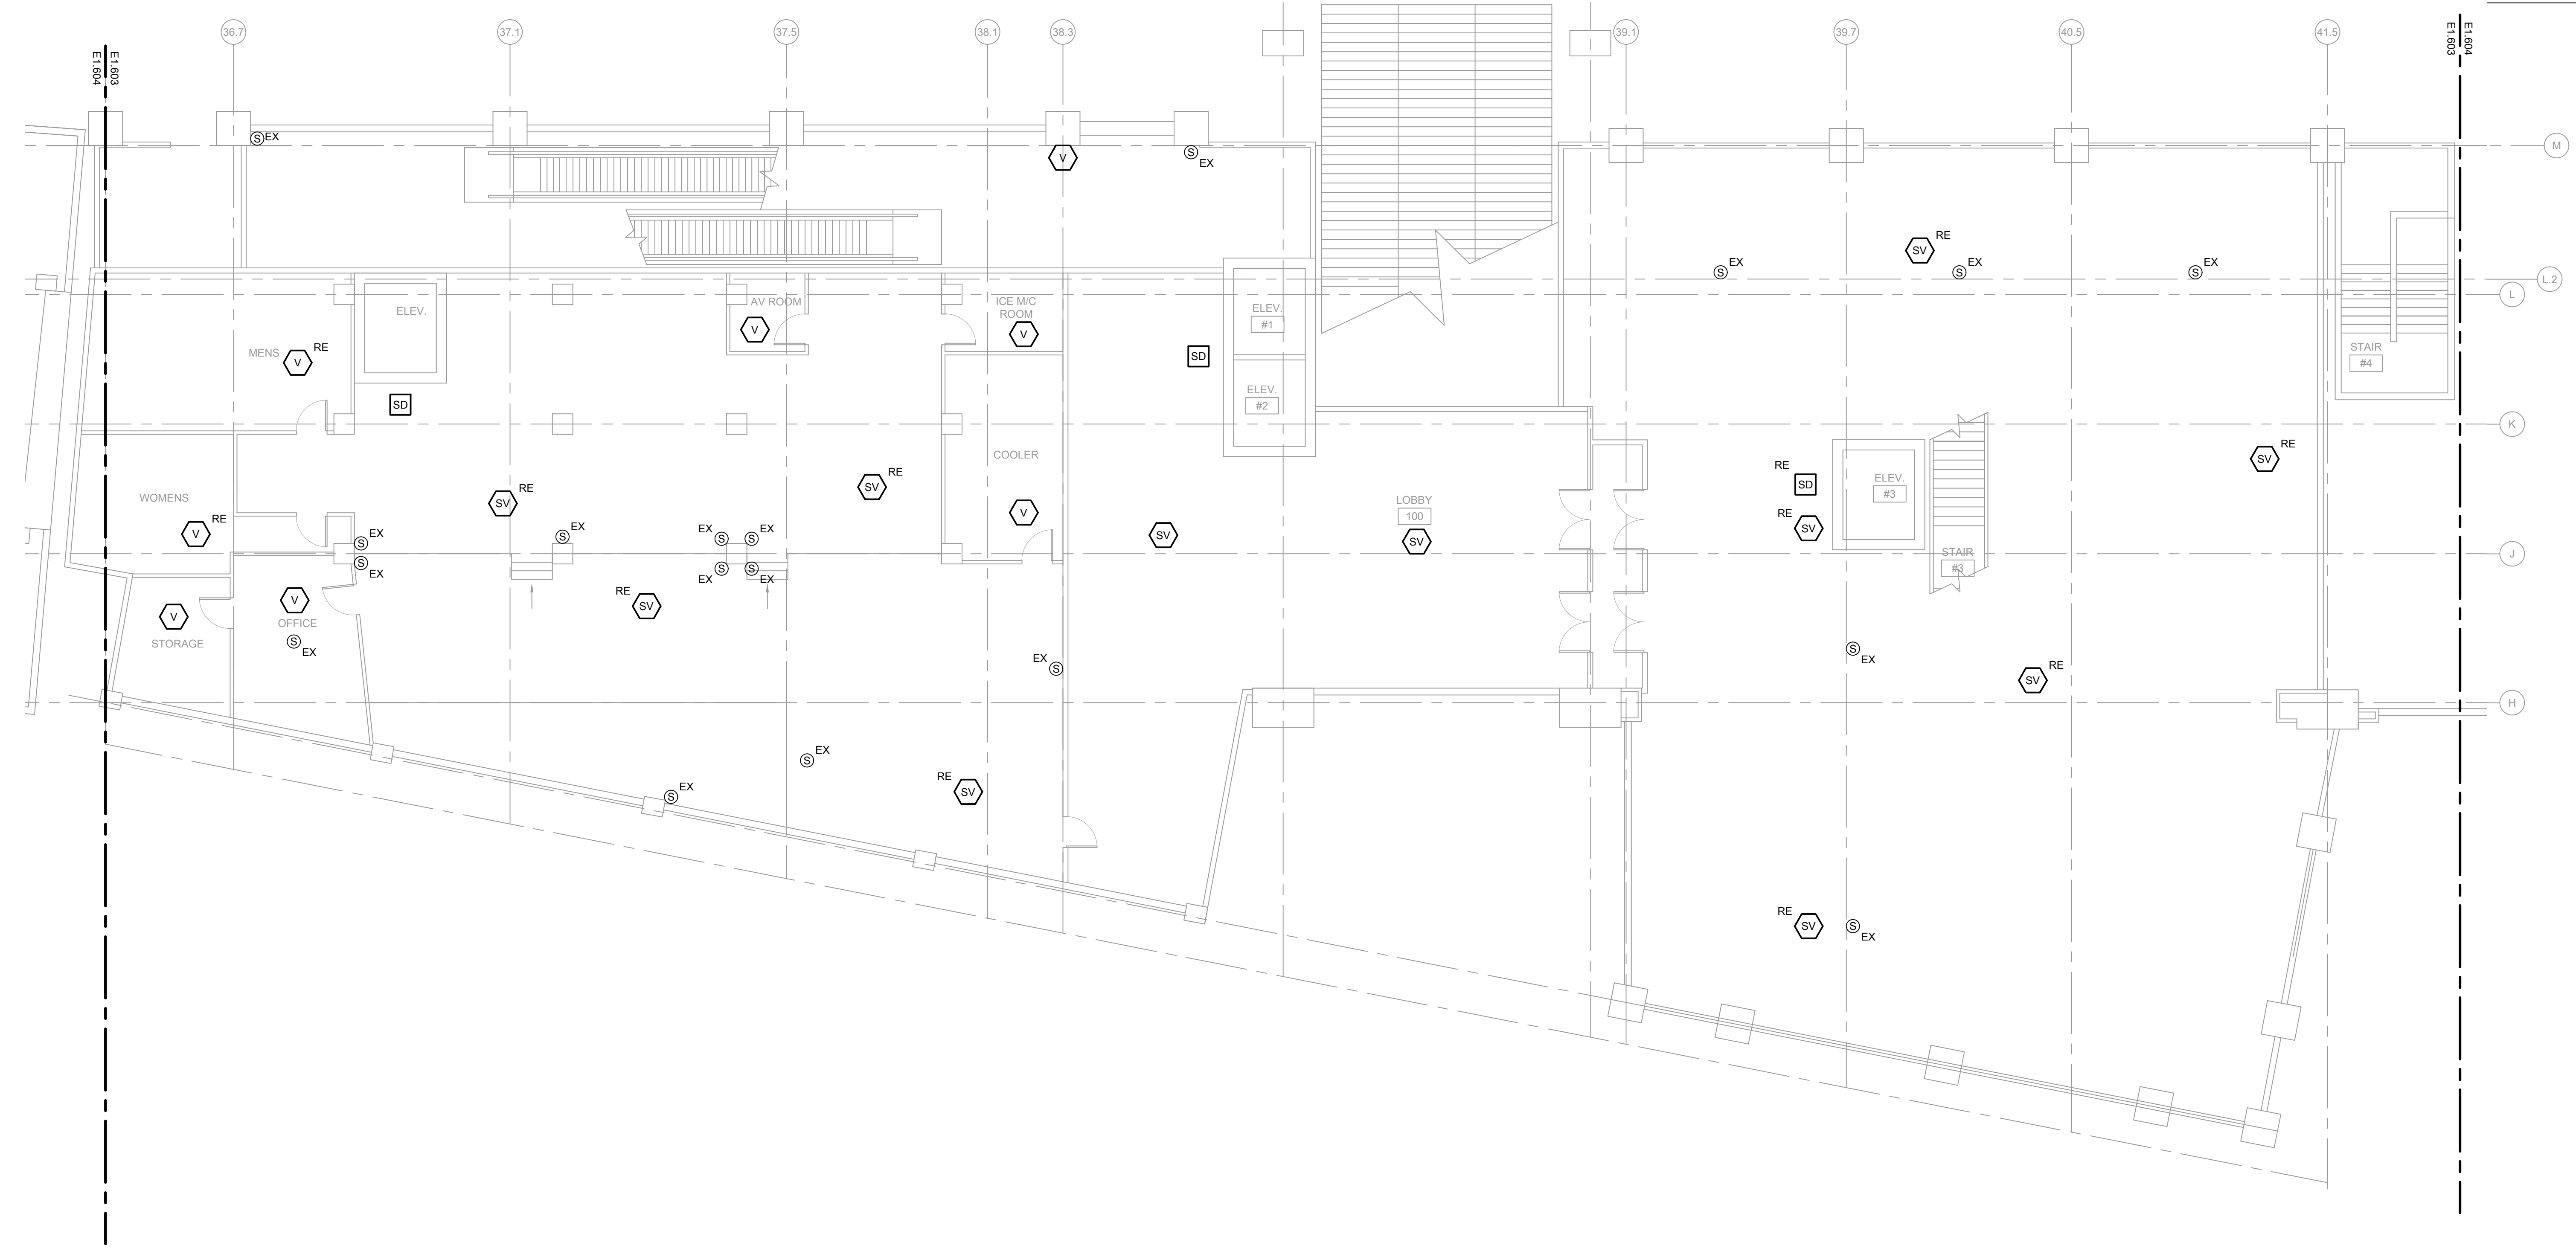

1 ELECTRICAL FIRE ALARM NEW WORK PLAN - MEZZANINE LEVEL - 320 W 35TH - SECTION 2

SCALE: 1/8" = 1'-0"

KEY PLAN:

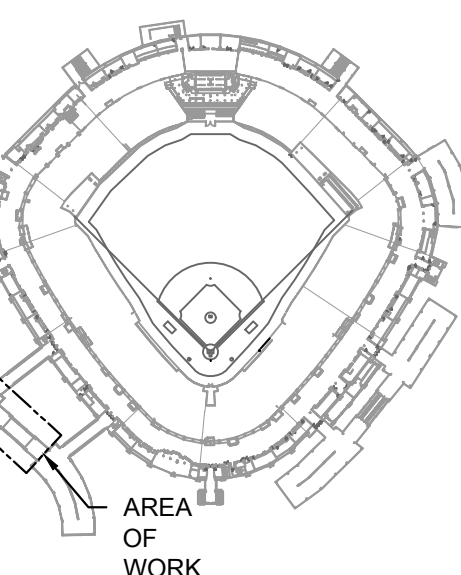

ISSUE/REVISION:

REV.	DATE	DESCRIPTION
1	10/03/2023	ISSUED FOR BID
1	10/18/2023	ADDENDUM 1

PROJECT:

GUARANTEED RATE FIELD -
FIRE ALARM REPLACEMENT

333 W 35TH STREET,
CHICAGO, ILLINOIS 60616

DRAWING TITLE:

ELECTRICAL FIRE ALARM NEW
WORK PLAN - MEZZANINE

DESIGNED BY: MR

CHECKED BY: BT


PROJECT NO: 22096

SCALE: 1/8" = 1'-0"

SHEET NO:

KEYED ELECTRICAL NEW WORK SHEET NOTES

A2. ALTERNATE 2: FURNISH AND INSTALL WEATHER PROOF VISUAL FIRE ALARM DEVICE. FURNISH AND INSTALL NEW WIRING AND CONDUIT AS REQUIRED. CONTRACTOR TO DETERMINE BEST MOUNTING LOCATION BASED ON FIELD CONDITIONS.

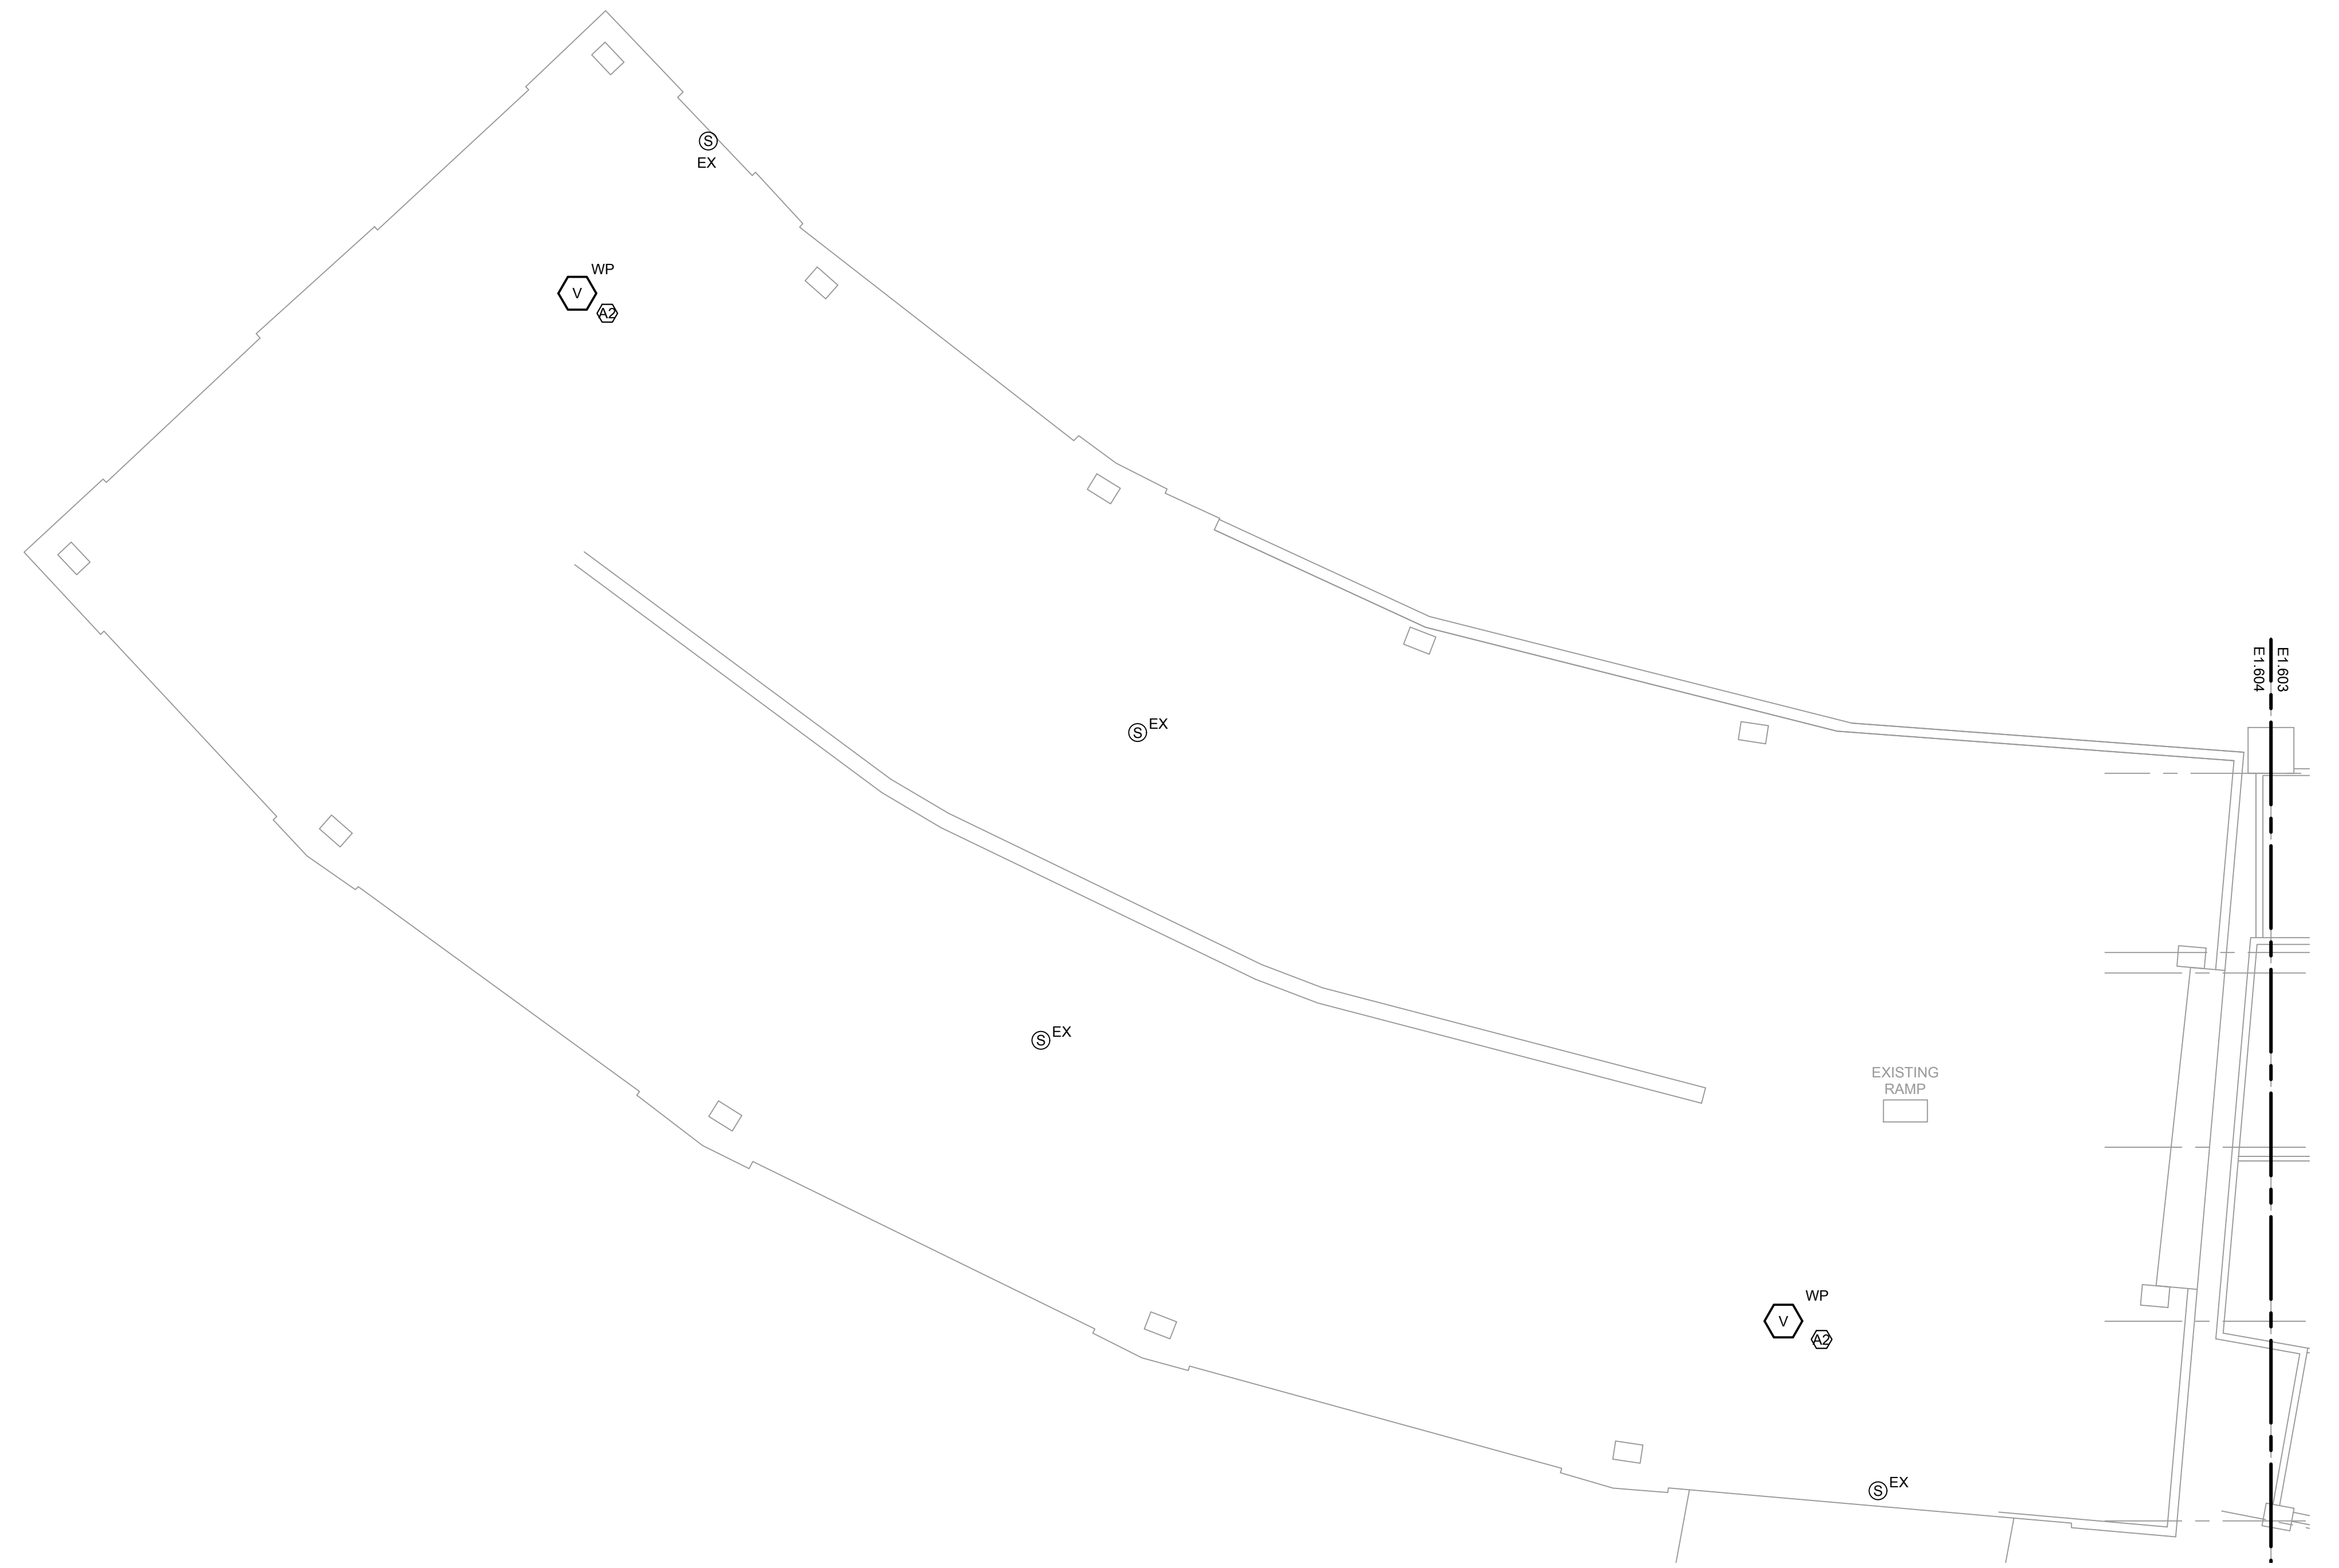


1

ELECTRICAL FIRE ALARM NEW WORK PLAN - MEZZANINE LEVEL - 320 W 35TH - SECTION 1

SCALE: 1/8" = 1'-0"

0 2 4 6 8 10'

North Arrow

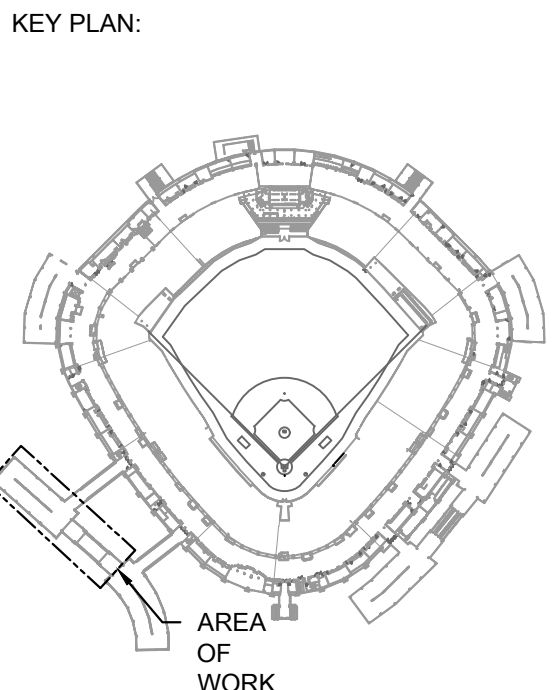


ISSUE/REVISION:		
REV.	DATE	DESCRIPTION
	10/03/2023	ISSUED FOR BID
1	10/18/2023	ADDENDUM 1

PROJECT:
GUARANTEED RATE FIELD -
FIRE ALARM REPLACEMENT


333 W 35TH STREET,
CHICAGO, ILLINOIS 60616

DRAWING TITLE:
ELECTRICAL FIRE ALARM NEW
WORK PLAN - MEZZANINE

DESIGNED BY:	MR
CHECKED BY:	BT
PROJECT NO:	22096
SCALE:	1/8" = 1'-0"
SHEET NO.	

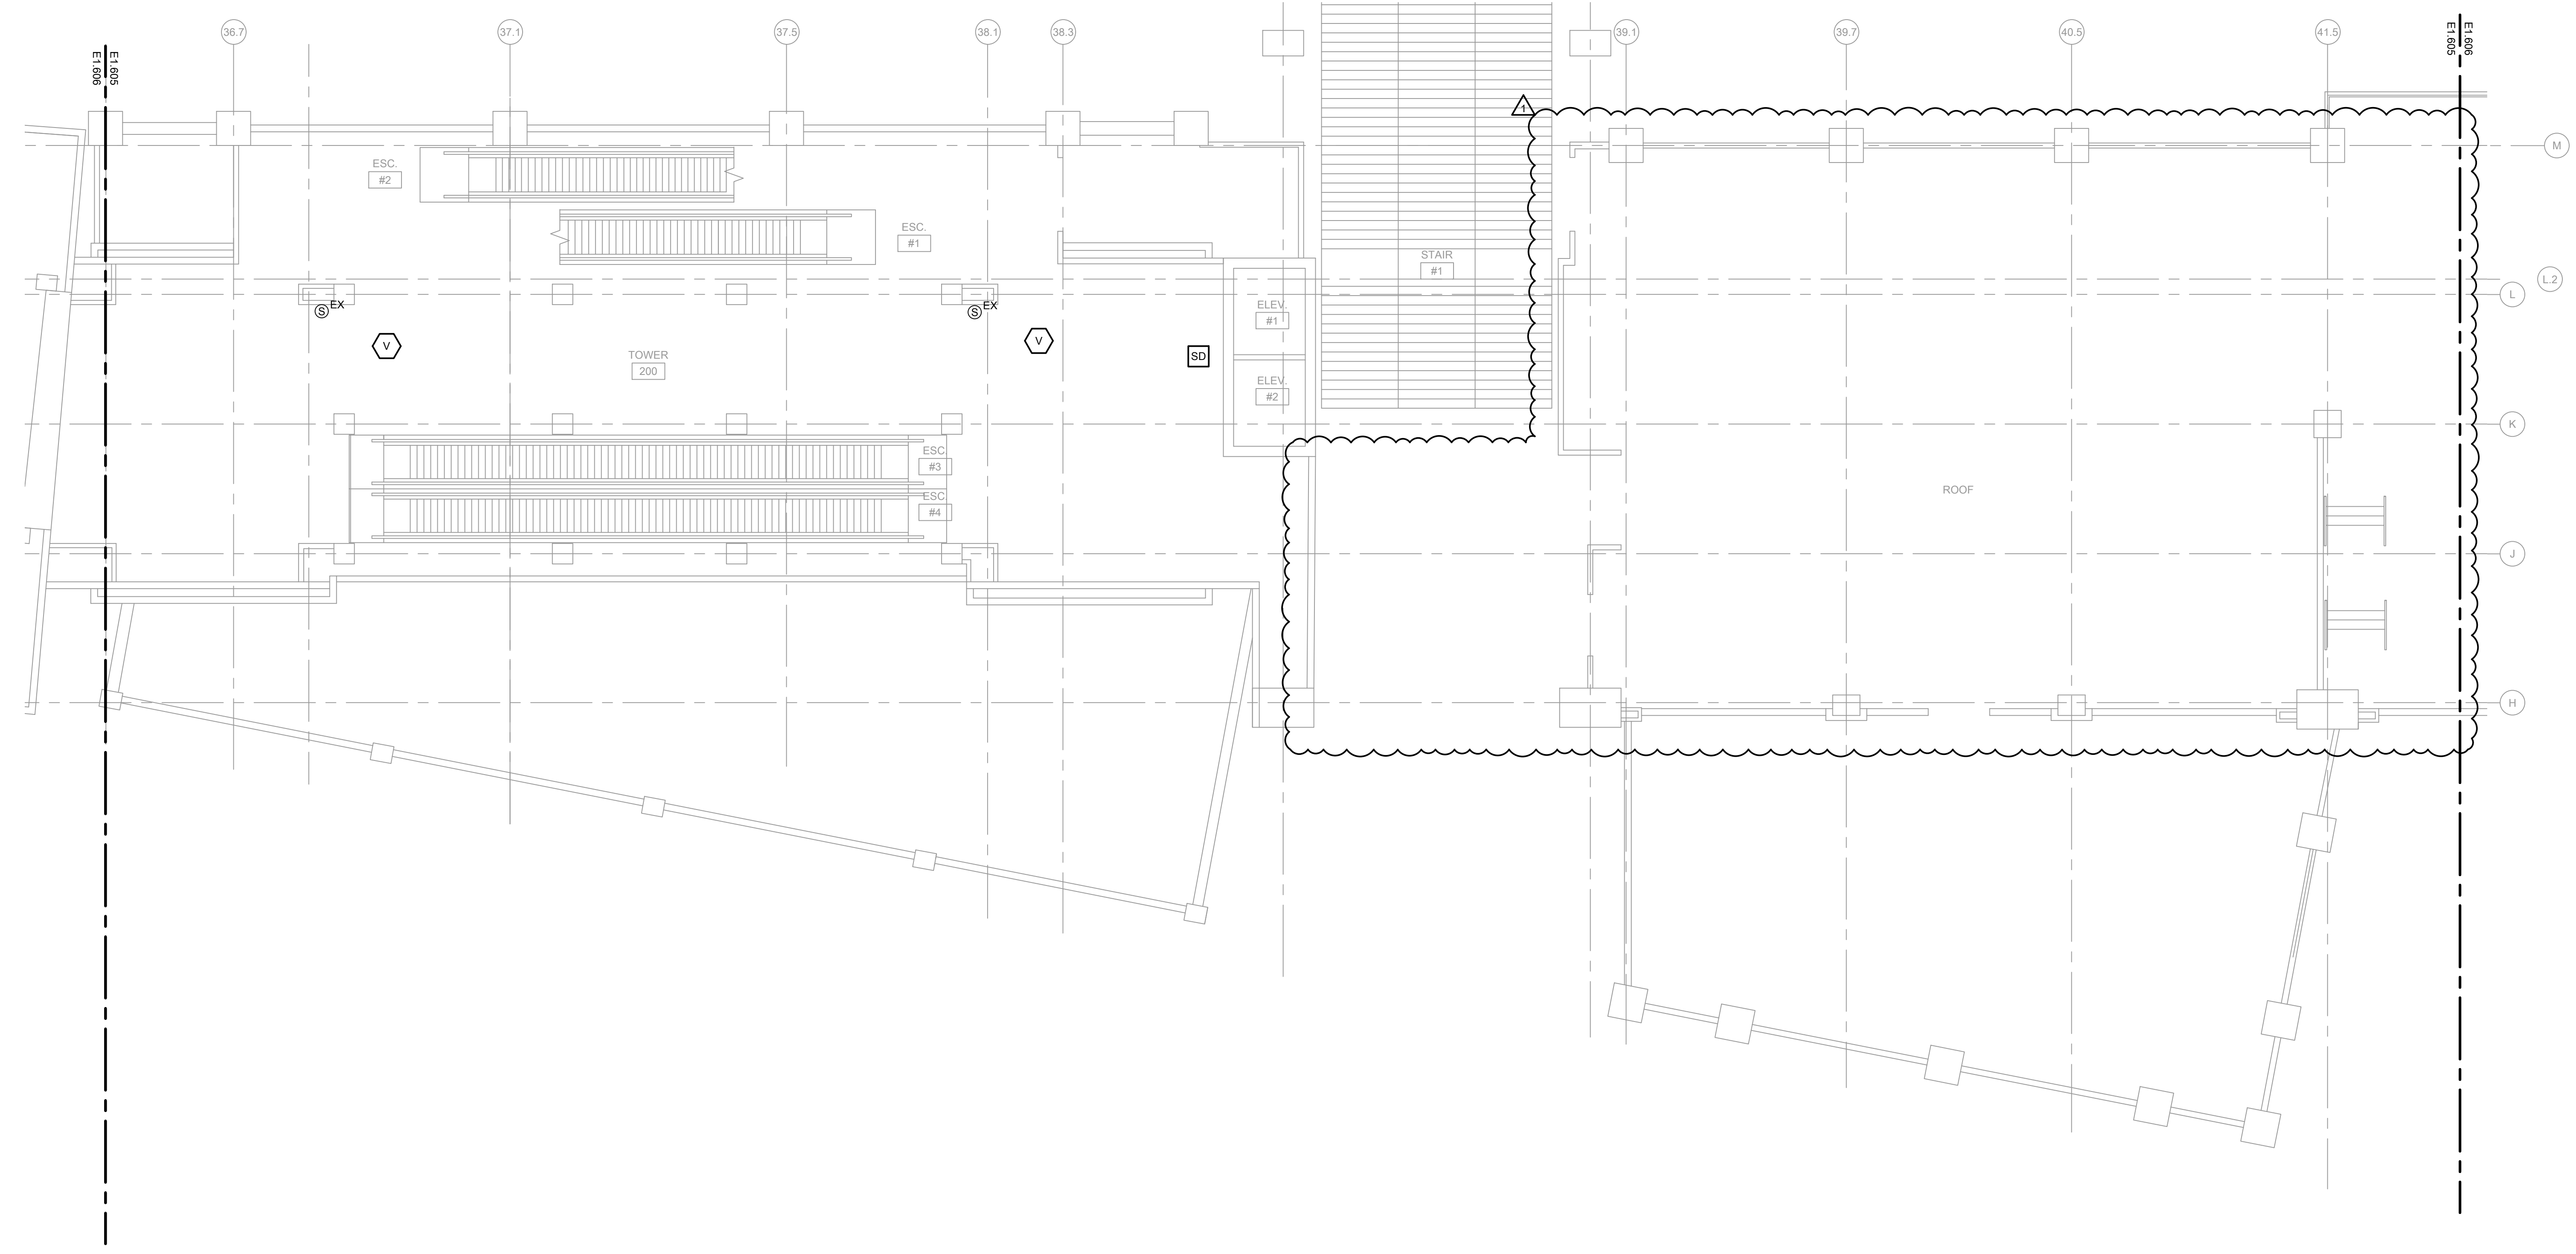

1 ELECTRICAL FIRE ALARM NEW WORK PLAN - MAIN CONCOURSE LEVEL - 320 W 35TH - SECTION 2

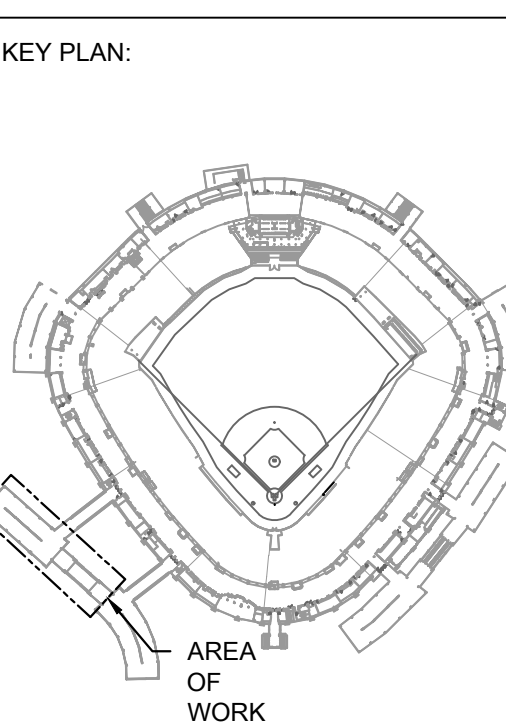

ISSUE/REVISION:		
REV.	DATE	DESCRIPTION
1	10/03/2023	ISSUED FOR BID
1	10/18/2023	ADDENDUM 1

PROJECT:
GUARANTEED RATE FIELD -
FIRE ALARM REPLACEMENT

333 W 35TH STREET,
CHICAGO, ILLINOIS 60616

DRAWING TITLE:
ELECTRICAL FIRE ALARM NEW
WORK PLAN - MAIN
CONCOURSE LEVEL



DESIGNED BY:	MR
CHECKED BY:	BT
PROJECT NO:	22096
SCALE:	1/8" = 1'-0"
SHEET NO.	

KEYED ELECTRICAL NEW WORK SHEET NOTES

A2. ALTERNATE 2: FURNISH AND INSTALL WEATHER PROOF VISUAL FIRE ALARM DEVICE. FURNISH AND INSTALL NEW WIRING AND CONDUIT AS REQUIRED. CONTRACTOR TO DETERMINE BEST MOUNTING LOCATION BASED ON FIELD CONDITIONS.



1 ELECTRICAL FIRE ALARM NEW WORK PLAN - CLUB LEVEL - 320 W 35TH - SECTION 1

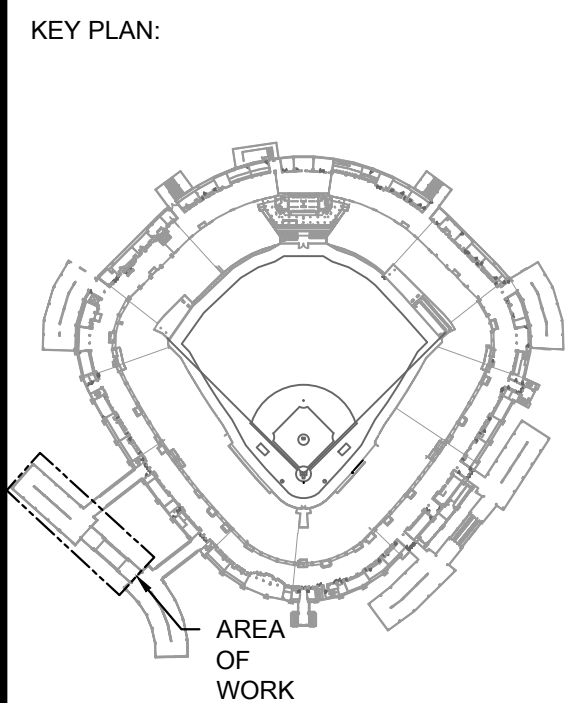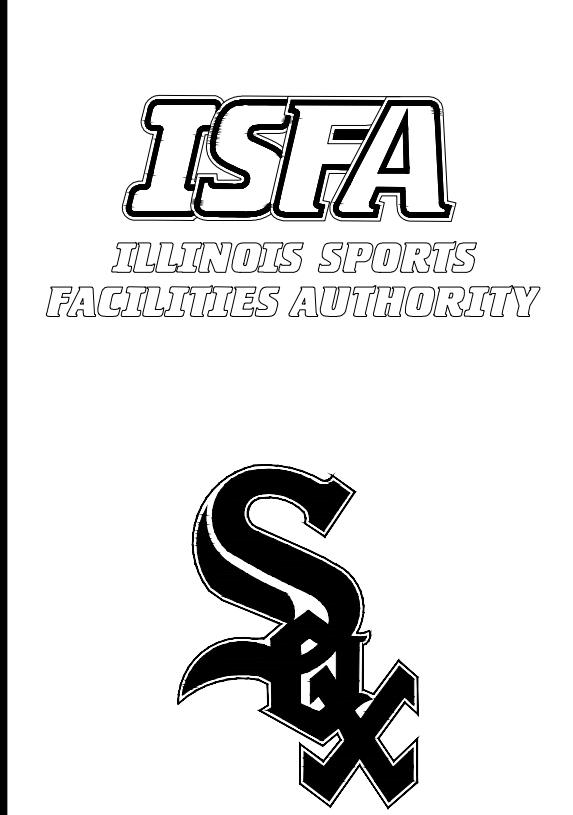

ISSUE/REVISION:		
REV.	DATE	DESCRIPTION
	10/03/2023	ISSUED FOR BID
1	10/18/2023	ADDENDUM 1

PROJECT:
GUARANTEED RATE FIELD -
FIRE ALARM REPLACEMENT

333 W 35TH STREET,
CHICAGO, ILLINOIS 60616

DRAWING TITLE:
ELECTRICAL FIRE ALARM NEW
WORK PLAN - CLUB LEVEL


DESIGNED BY:	MR
CHECKED BY:	BT
PROJECT NO:	22096
SCALE:	1/8" = 1'-0"
SHEET NO.	

10/03/2023ISSUED FOR BID

PRELIMINARY - NOT FOR CONSTRUCTION

E1.608

1. RISER DIAGRAM ABOVE IS DIAGRAMMATIC AND IS SHOWN TO PROVIDE A GENERAL OVERVIEW OF MAJOR SYSTEM COMPONENTS AND THEIR INTERCONNECTIONS. THIS DIAGRAM IS NOT TO BE USED FOR FIELD INSTALLATION PURPOSES.
2. SEE PLANS FOR DEVICE LOCATIONS AND QUANTITIES.
3. PROVIDE ALL ANCILLARY COMPONENTS, HARDWARE, POWER CONNECTIONS, NAC PANEL, AMPLIFIER PANEL, AND WIRING AS REQUIRED FOR A COMPLETE AND OPERATING FIRE ALARM SYSTEM.
4. ALL WIRING SHALL BE IN CONDUIT, 3/4" MINIMUM. ALL JUNCTION BOX SHALL HAVE RED COVER. ALL WIRING SHALL BE PROVIDED PER MANUFACTURER'S RECOMMENDATIONS.
5. ALL STROBES SHALL BE SYNCHRONIZED

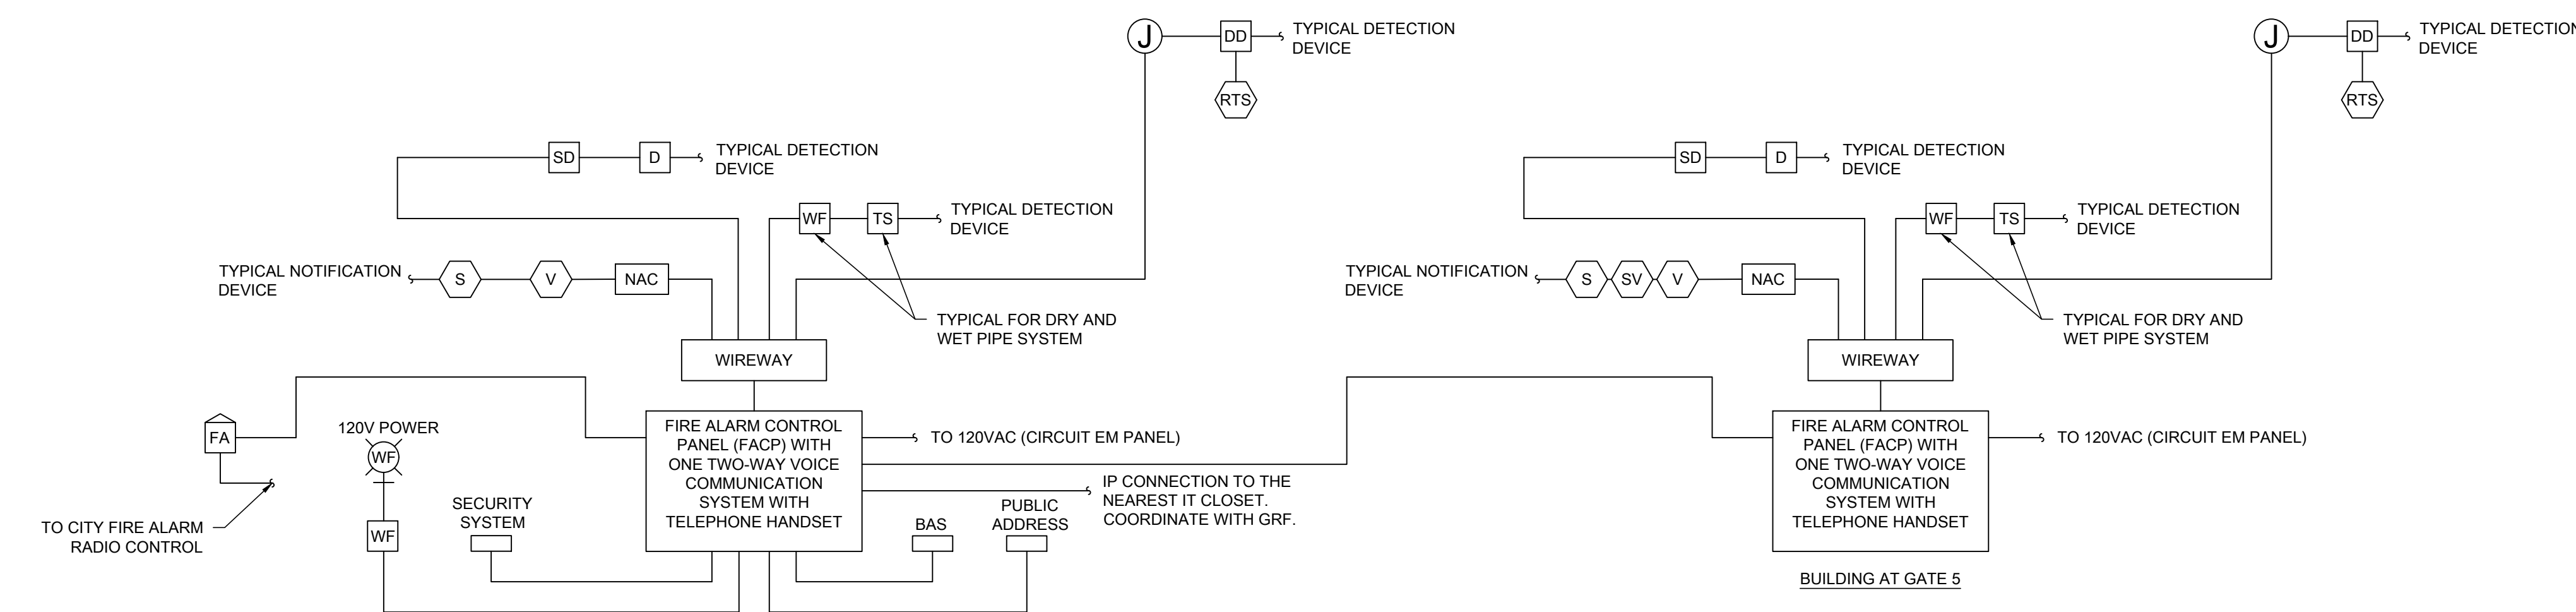

LEVEL 1

1 FIRE ALARM RISER DIAGRAM

SCALE: NO SCALE

[illegible]

PROJECT:
GUARANTEED RATE FIELD -
FIRE ALARM REPLACEMENT

333 W 35TH STREET,
CHICAGO, ILLINOIS 60616

DRAWING TITLE:
ELECTRICAL DETAILS

DESIGNED BY:	LF
CHECKED BY:	BT
PROJECT NO:	22096

SCALE: NO SCALE

SHEET NO.

50 001

10/03/2023 ISSUED FOR BID

PRELIMINARY - NOT FOR CONSTRUCTION

E2.001